


2
A-101
1/4" = 1'-0"
DEMOLITION PLAN

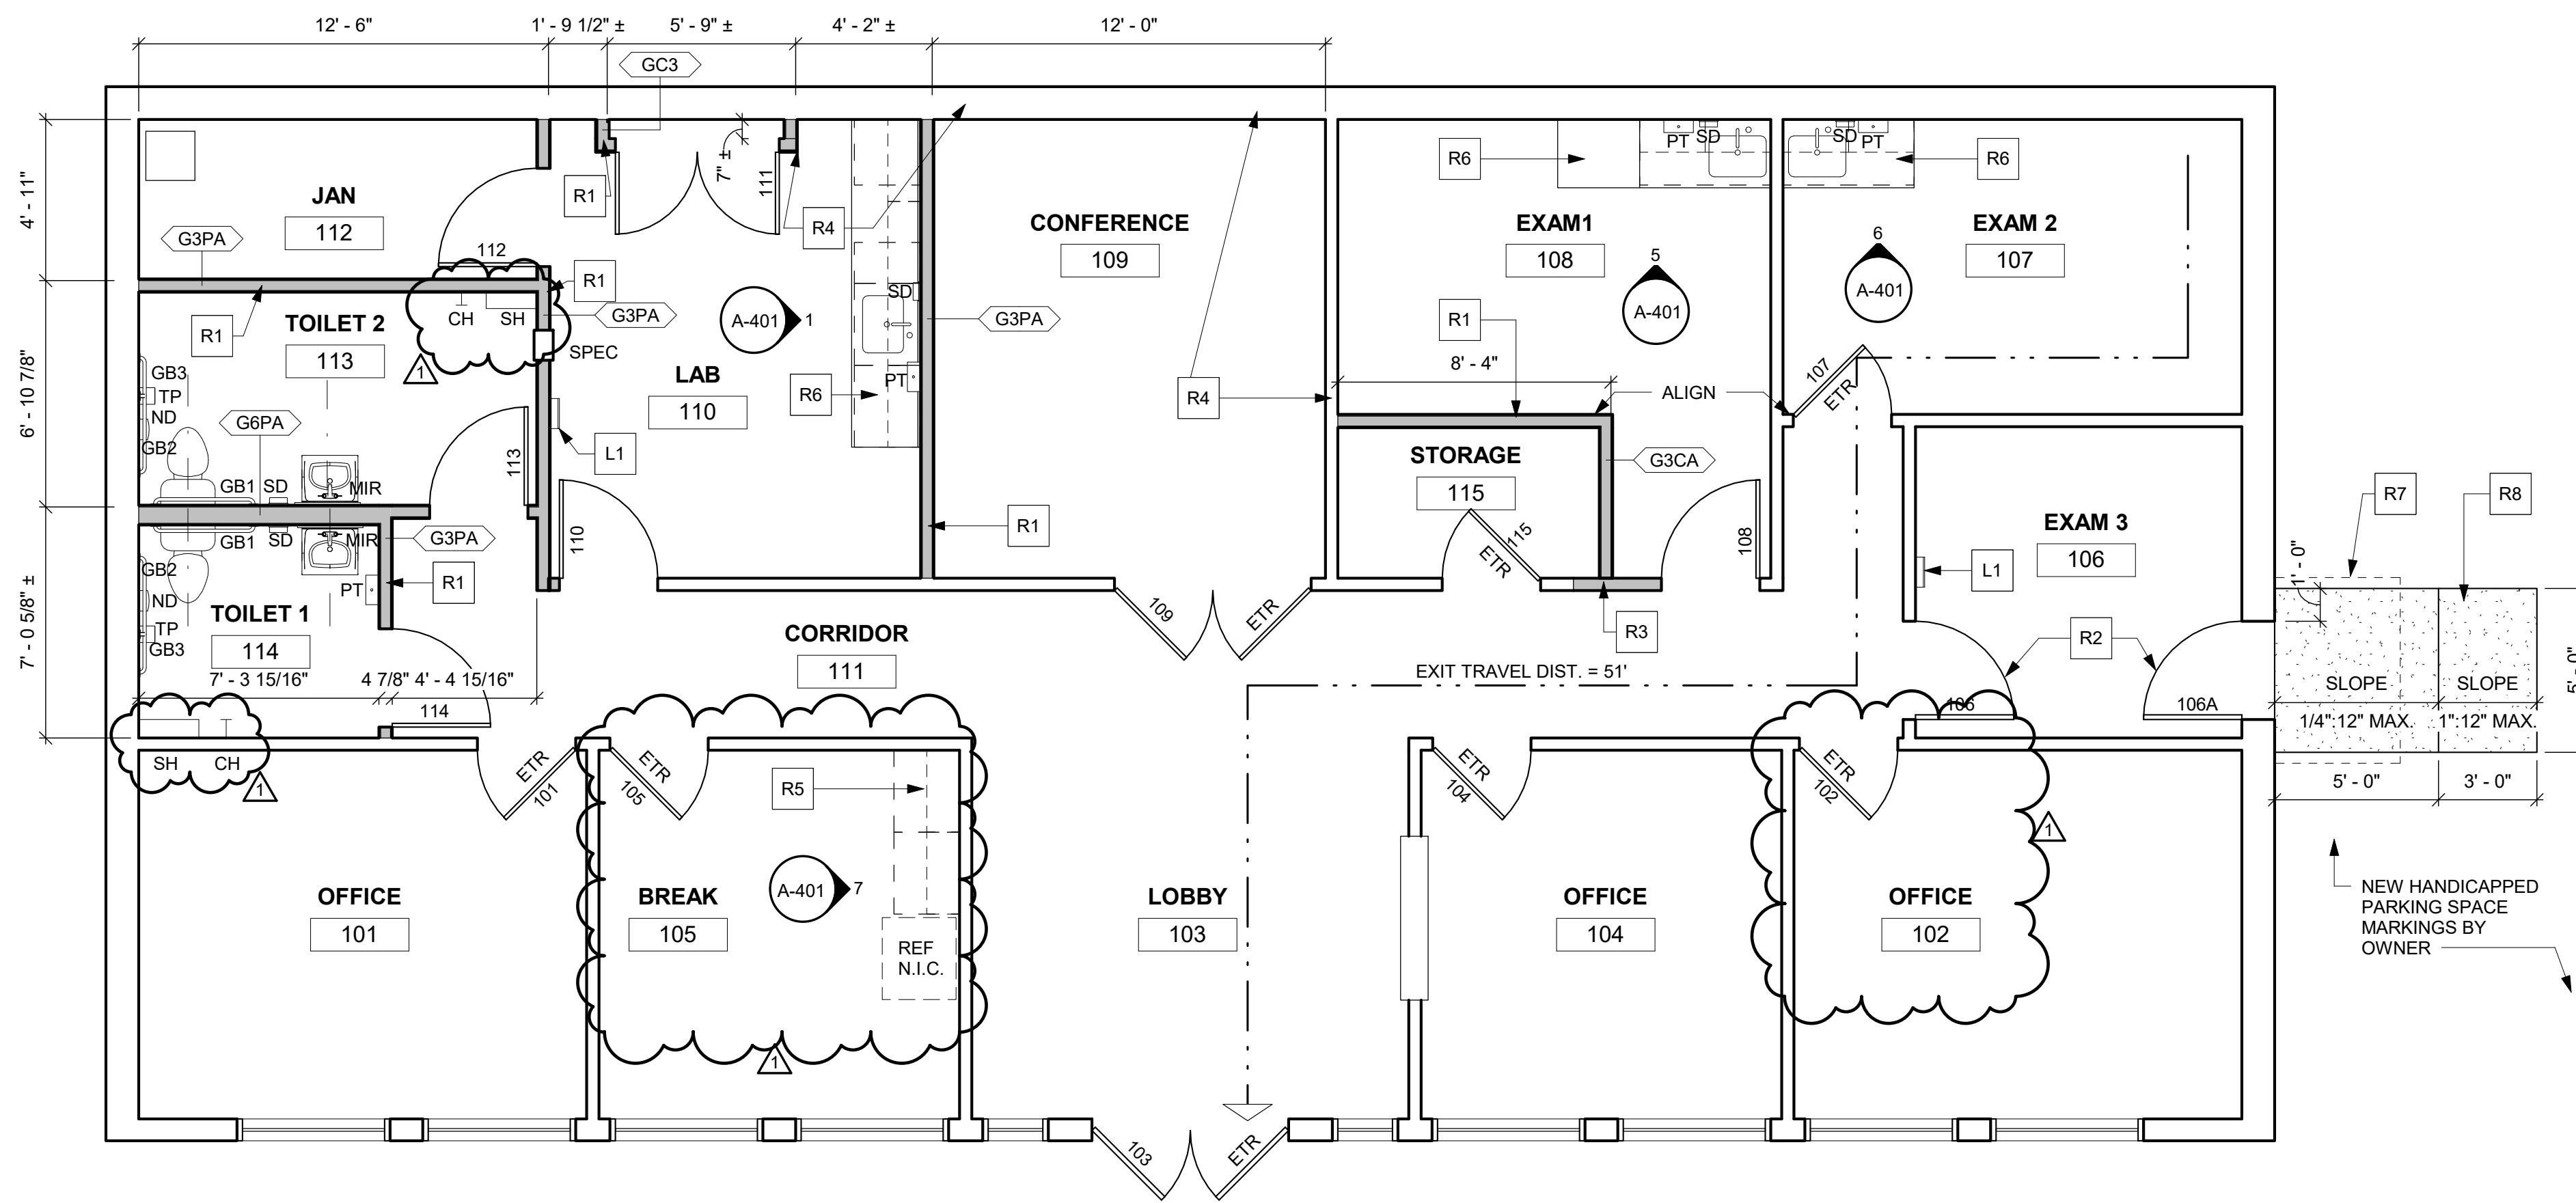

1
A-101
1/4" = 1'-0"
FIRST FLOOR PLAN

GENERAL DEMOLITION NOTES

1. SEE G-002 FOR GENERAL DEMOLITION NOTES.

DEMOLITION NOTES

- D1. REMOVE DRYWALL PARTITION.
- D2. REMOVE DOOR AND FRAME.
- D3. REMOVE COUNTER.
- D4. REMOVE FLOOR TILE OR CARPET, PREPARE FLOOR FOR NEW FLOOR FINISH.
- D5. REMOVE SECTION OF WALL FOR INSTALLATION OF NEW DOOR.
- D6. REMOVE EXISTING DOOR AND SALVAGE FOR REINSTALLATION.
- D7. REMOVE PLUMBING FIXTURES AND CABINETS.
- D8. REMOVE SECTION OF CONCRETE SLAB AS REQUIRED FOR INSTALLATION OF NEW PLUMBING. REMOVE SLAB AS REQUIRED LEAVING FLOOR READY FOR NEW FLOOR FINISH.
- D9. REMOVE

GENERAL CONSTRUCTION NOTES

1. SEE G-002 FOR GENERAL CONSTRUCTION NOTES.

NOTES LEGEND

A - MISCELLANEOUS	G - DOORS / GLAZINGS	P - PLUMBING
C - CIVIL	K - FURNITURE / FINISHES	R - ROOF
E - ELECTRICAL	L - LIFE SAFETY	S - STRUCTURAL
F - FLOORS / CEILINGS	M - MECHANICAL	W - WALLS

FLOOR PLAN NOTES



- L1 - FIRE EXTINGUISHER BY OWNER
- R1 - INSTALL NEW DRYWALL PARTITION.
- R2 - NEW FRAME AND DOOR.
- R3 - INFILL OPENING AT REMOVED DOOR WITH DRYWALL CONSTRUCTION TO MATCH EXISTING.
- R4 - REPAIR WALLS AT REMOVED COUNTERS
- R5 - NEW CASEWORK.
- R6 - NEW CASEWORK AND SINK.
- R7 - FUTURE CANOPY BY OWNER
- R8 - NEW CONCRETE SLAB TO ALIGN WITH FLOOR. SLAB TO ALIGN WITH ADJACENT PAVEMENT - MODIFY PAVEMENT AS REQUIRED.

DEMOLITION PLAN LEGEND


	INDICATES EXISTING CONSTRUCTION TO REMAIN
	INDICATES EXISTING CONSTRUCTION TO BE REMOVED
	INDICATES EXISTING DOOR TO REMAIN
	INDICATES EXISTING DOOR TO BE REMOVED

FLOOR PLAN LEGEND

	INDICATES EXISTING WALL CONSTRUCTION
	INDICATES NEW WALL CONSTRUCTION
	90 DEG. SWING INDICATES NEW DOOR
	45 DEG. SWING INDICATES EXISTING DOOR

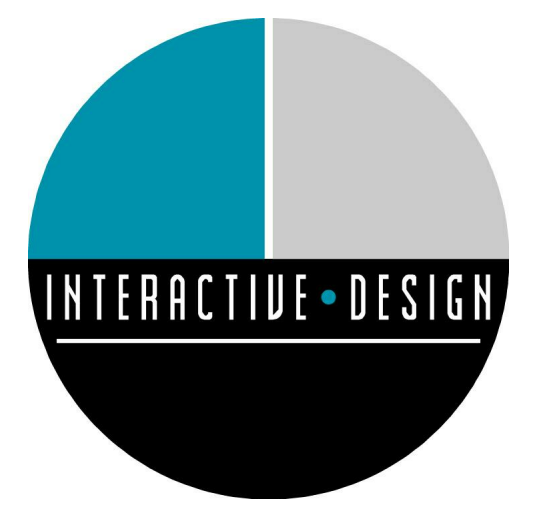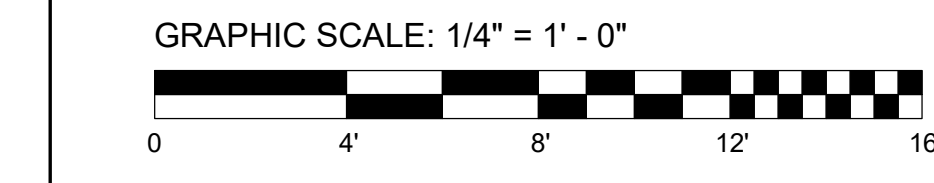

INTERACTIVE DESIGN GROUP
301 6TH STREET SW
ROANOKE, VA 24016
P. 540.342.7534 F. 540.342.7536

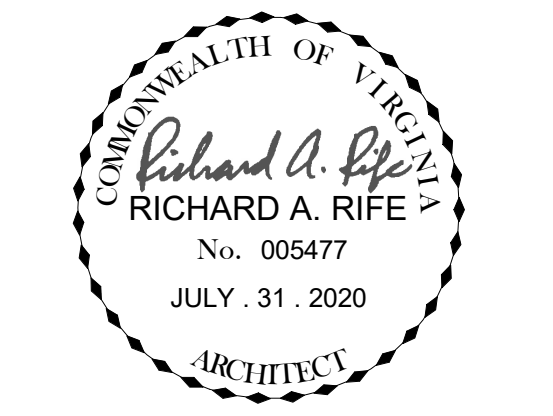

NO.	REVISIONS	DATE
1	OWNER CHANGES	09.21.20

RENOVATIONS TO
ROANOKE COUNTY EMPLOYEE HEALTH CENTER

2741 PENN FOREST BLVD.
ROANOKE, VA 24018

DATE	JULY 31 2020
DRAWN	AS
CHECKED	RAR
JOB	20-040

FLOOR PLAN

SHEET
A-101